





135 ALMERIA AVENUE
CORAL GABLES, FLORIDA 33134
(305) 446-2788 (PHONE)
(305) 443-5844 (FAX)
EB-00003791
www.sdmcorp.com

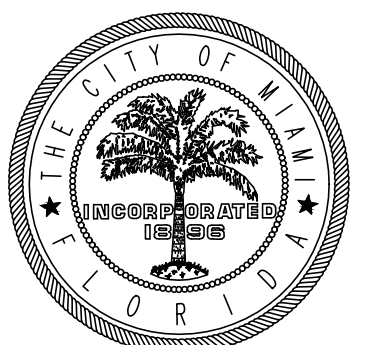

CITY OF MIAMI
CAPITAL IMPROVEMENTS PROGRAM

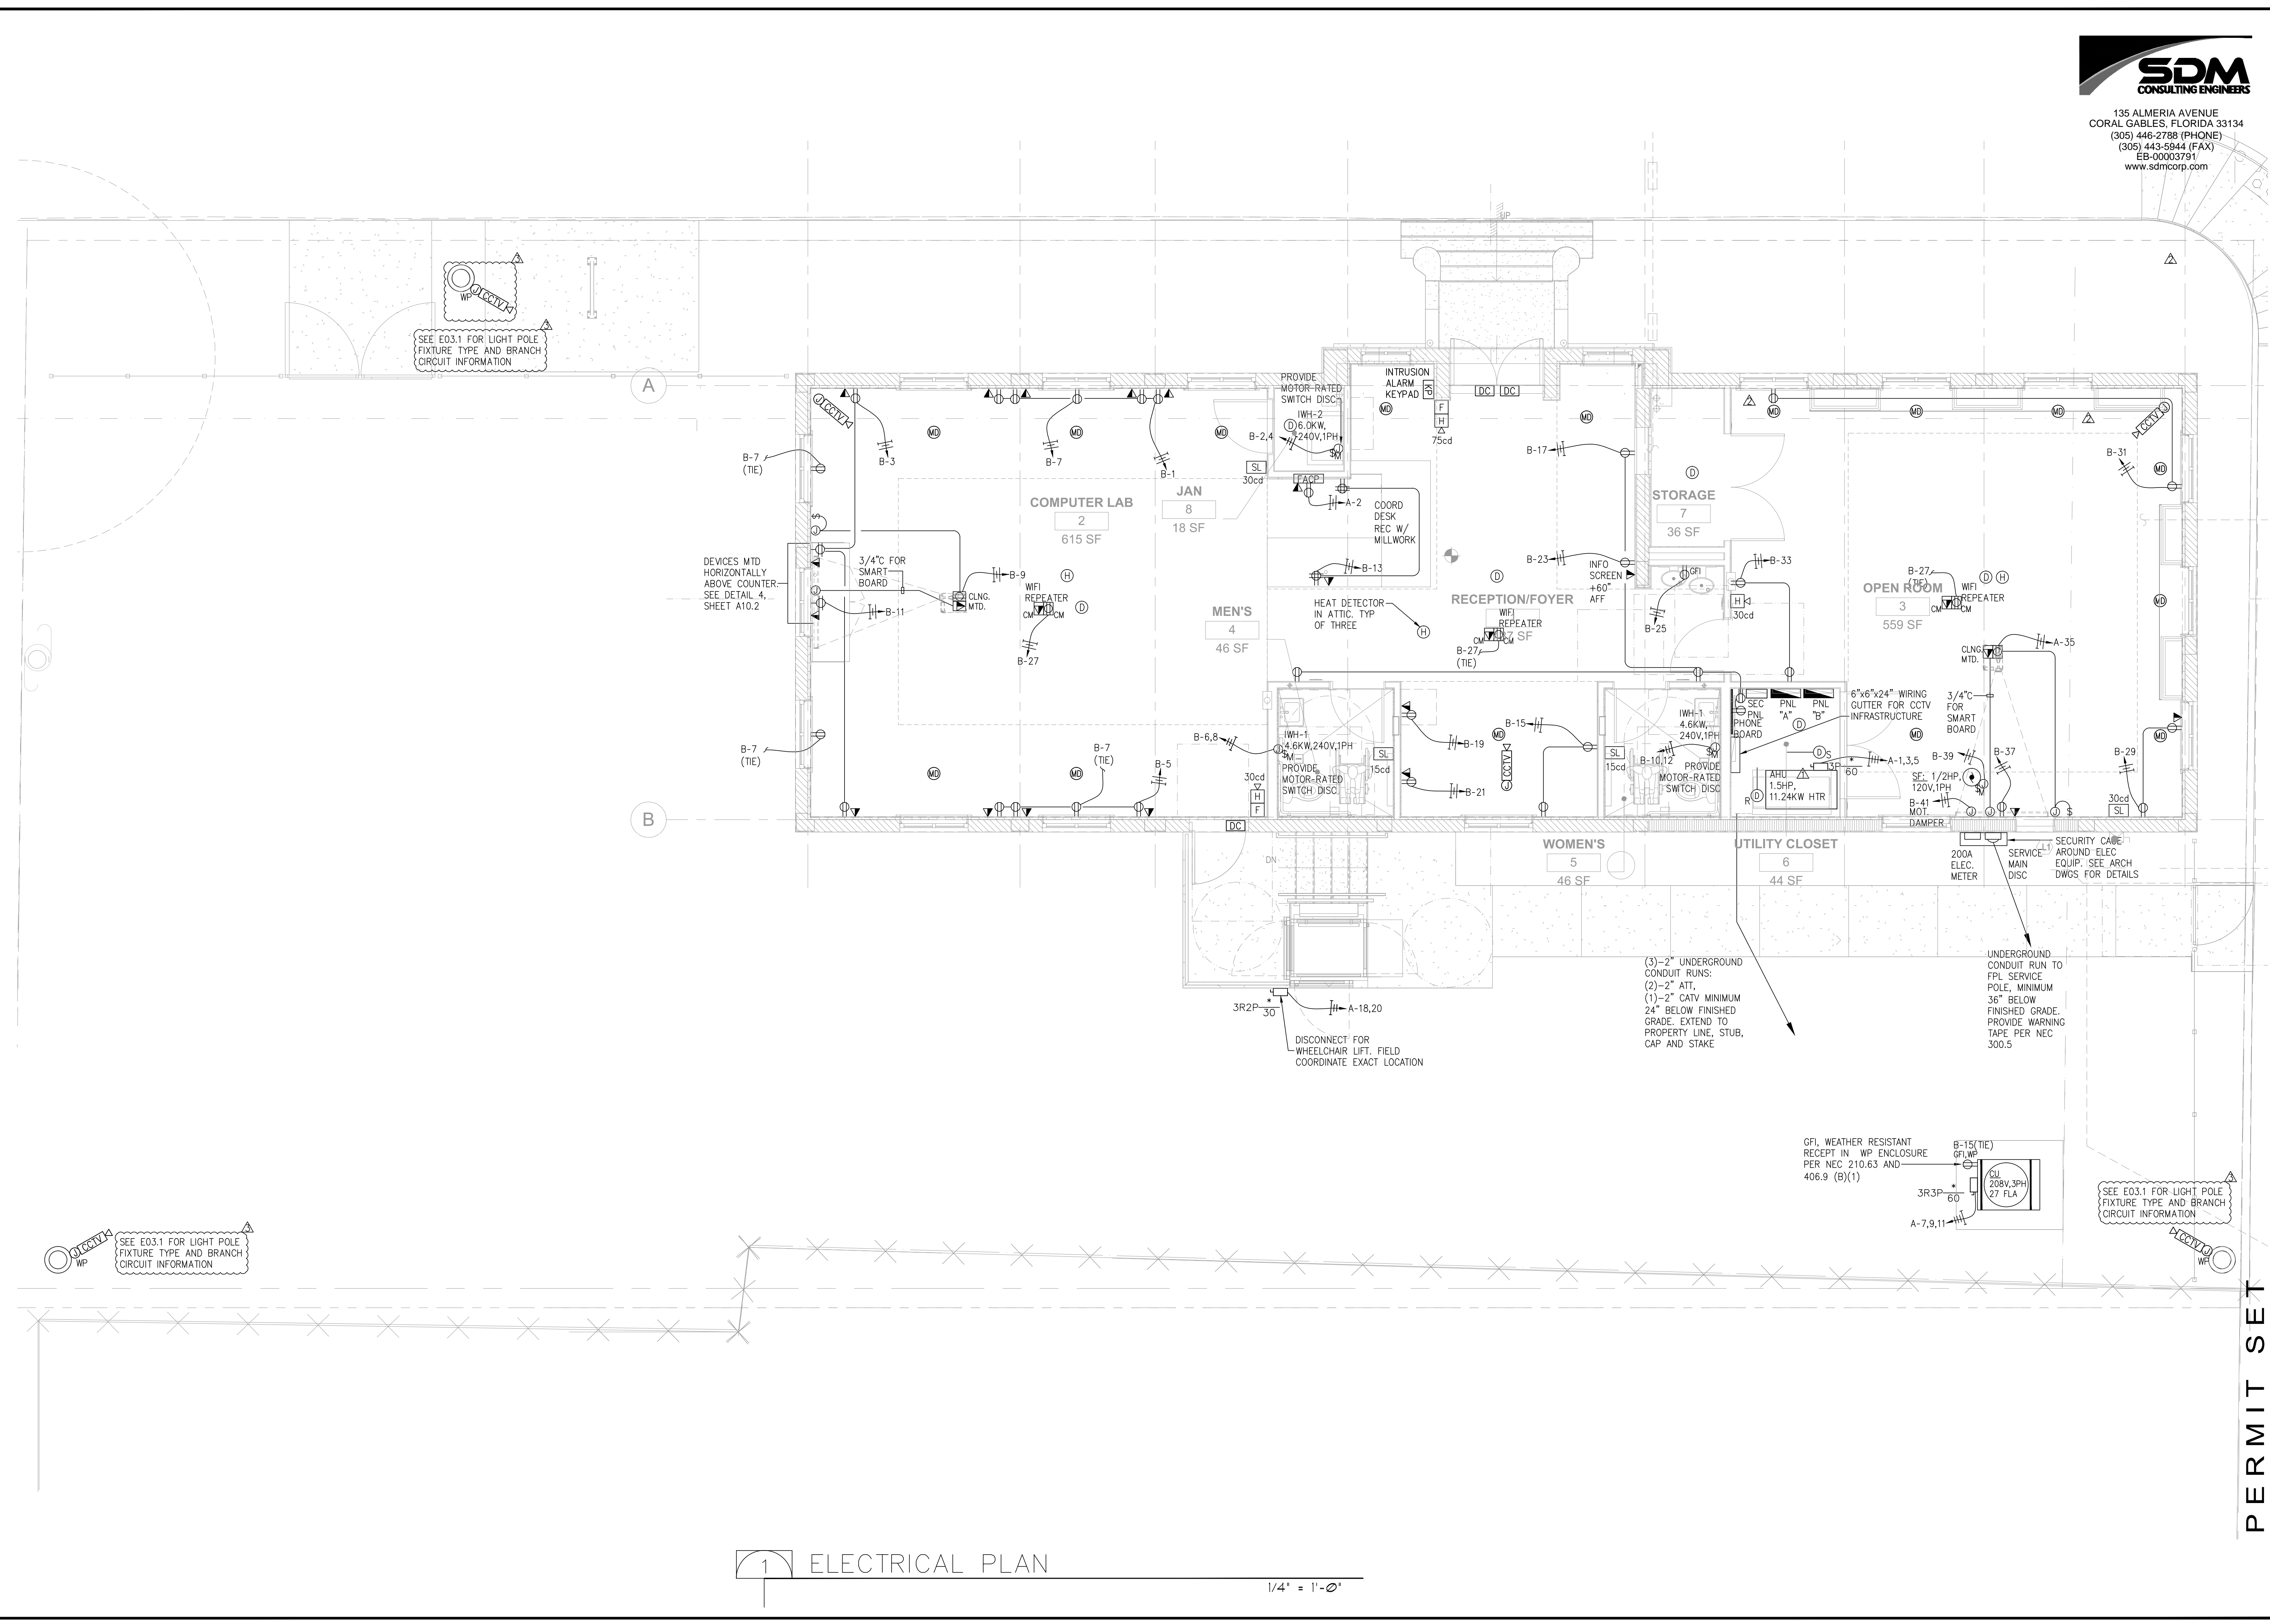


ELECTRICAL POWER AND SYSTEMS PLAN
DORSEY MEMORIAL LIBRARY RESTORATION
100 NW 17 STREET
MIAMI, FL. 33136

SHEET NAME:

DATE:	11/15/16
DESIGN:	MPM
DRAWN:	MPM
CHECKED:	MPM
REVISIONS:	
No.	Date
1	12/19/2016
2	02/24/2017
3	03/07/2017

JOB No. B-30531
FILE:

ENGINEER:
MANUEL PEREZ-MONTOYA, P.E.
SDM CONSULTING ENGINEERS, INC.
LICENSE No. 66220
PHONE: 305.446.2788

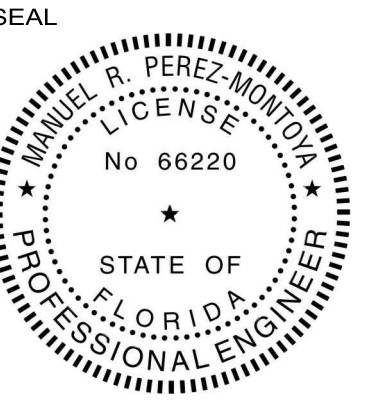

SCALE: AS SHOWN

SHEET No.

E02.1

OF SHEETS

1 ELECTRICAL PLAN

1/4" = 1'-0"

PERMIT SET